


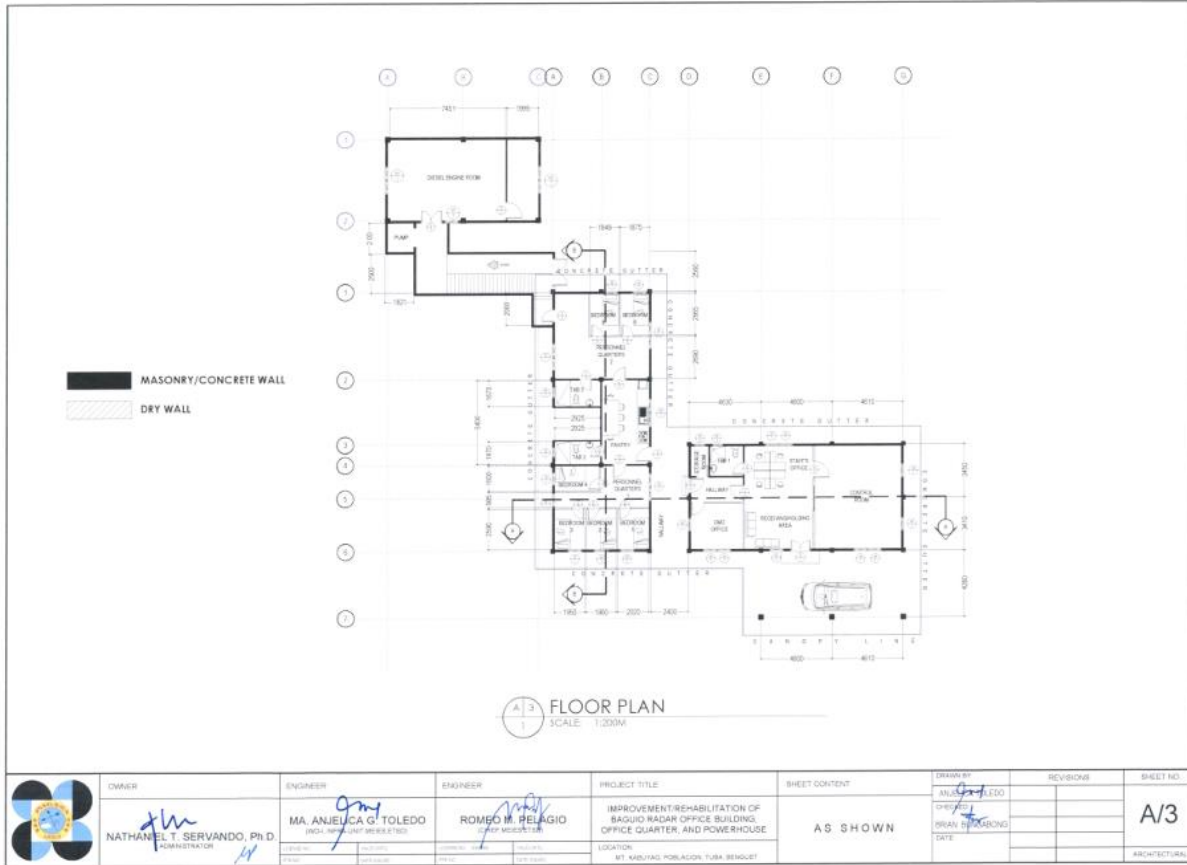
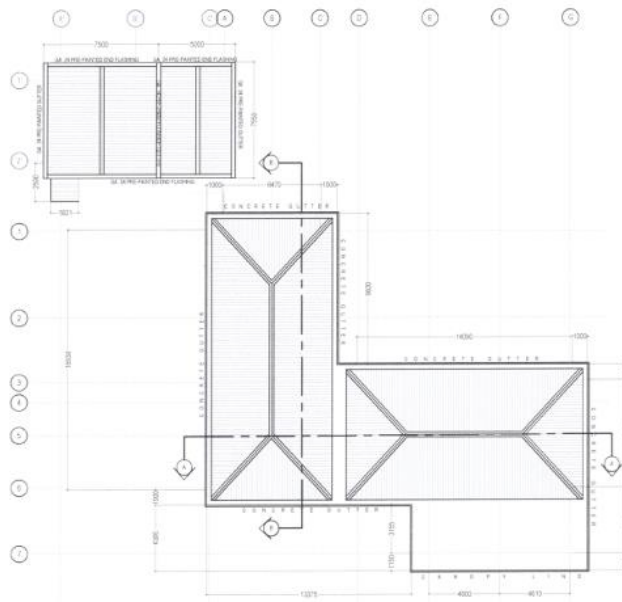
		TABLE OF CONTENTS ARCHITECTURAL A-1 PRELIMINARY SITE DEVELOPMENT PLAN A-2 PRELIMINARY FLOOR PLAN A-3 FLOOR PLAN A-4 ROOF PLAN A-5 SECTION THROUGH ROOF ELEVATION A-6 SECTION THROUGH ROOF ELEVATION A-7 SECTION THROUGH ROOF ELEVATION A-8 SECTION THROUGH ROOF ELEVATION A-9 SECTION THROUGH ROOF ELEVATION STRUCTURAL S-1 STRUCTURAL NOTES S-2 FOUNDATION PLAN S-3 COLUMN FOOTING DETAIL S-4 BEAM FOOTING DETAIL S-5 BEAM FOOTING DETAIL S-6 BEAM FOOTING DETAIL S-7 BEAM FOOTING DETAIL S-8 BEAM FOOTING DETAIL S-9 BEAM FOOTING DETAIL S-10 BEAM FOOTING DETAIL PLUMBING P-1 STORM DRAINAGE LAYOUT P-2 STORM DRAINAGE LAYOUT ELECTRICAL E-1 ELECTRICAL NOTES AND SPECIFICATIONS E-2 LIGHTING LAYOUT E-3 POWER LAYOUT E-4 NETWORK AND CABLE LAYOUT E-5 FIRE ALARM SYSTEM LAYOUT E-6 FIRE ALARM SYSTEM LAYOUT E-7 FIRE ALARM SYSTEM LAYOUT E-8 FIRE ALARM SYSTEM LAYOUT E-9 FIRE ALARM SYSTEM LAYOUT E-10 FIRE ALARM SYSTEM LAYOUT MECHANICAL M-1 MECHANICAL NOTES M-2 MECHANICAL NOTES M-3 MECHANICAL NOTES M-4 MECHANICAL NOTES M-5 MECHANICAL NOTES M-6 MECHANICAL NOTES M-7 MECHANICAL NOTES M-8 MECHANICAL NOTES M-9 MECHANICAL NOTES M-10 MECHANICAL NOTES Other O-1 OTHER NOTES O-2 OTHER NOTES O-3 OTHER NOTES O-4 OTHER NOTES O-5 OTHER NOTES O-6 OTHER NOTES O-7 OTHER NOTES O-8 OTHER NOTES O-9 OTHER NOTES O-10 OTHER NOTES		Republic of the Philippines Department of Public Works & Highways OFFICE OF THE BUILDING OFFICIAL TUBA, BENGUET District/City/Municipality Land Use and Zoning Line & Grade Architectural Structural Sanitary Electrical Mechanical Bureau of Fire Protection	
							
							
							
P E R S P E C T I V E		L O C A T I O N M A P					
		OWNER NATHANIEL T. SERVANDO, Ph.D. ADMINISTRATOR		ENGINEER MA. ANJELICA G. TOLEDO REGISTERED ARCHITECT		ENGINEER ROMEO M. PELAYO REGISTERED ARCHITECT	
PROJECT TITLE IMPROVEMENT/REHABILITATION OF BAGUIO RADAR OFFICE BUILDING, OFFICE QUARTER, AND POWERHOUSE		LOCATION MT. ANILYNO Poblacion, Tuba, Benguet		SHEET CONTENT AS SHOWN		SHEET NO. A/1	








ROOF PLAN
SCALE: 1:200M

	OWNER NATHANIEL T. SERVANDO, Ph.D. ADMINISTRATOR	ENGINEER MA ANJELICA G. TOLEDO (REG. ARCHT. NO. 10582783)	ENGINEER ROMEO B. RELAGIDO (REG. ARCHT. NO. 10582783)	PROJECT TITLE IMPROVEMENT/REHABILITATION OF BAGUIO RADAR OFFICE BUILDING, OFFICE QUARTER, AND POWERHOUSE LOCATION 811 KASATAG, POBLACION, TUBA, DENZEL	SHEET CONTENT AS SHOWN	DESIGNED BY ANJELICA G. TOLEDO CHECKED BY ROMEO B. RELAGIDO DATE 10/10/2023	REVISIONS	SHEET NO. A/4 ARCHITECTURAL
--	--	---	---	---	---	---	------------------	---

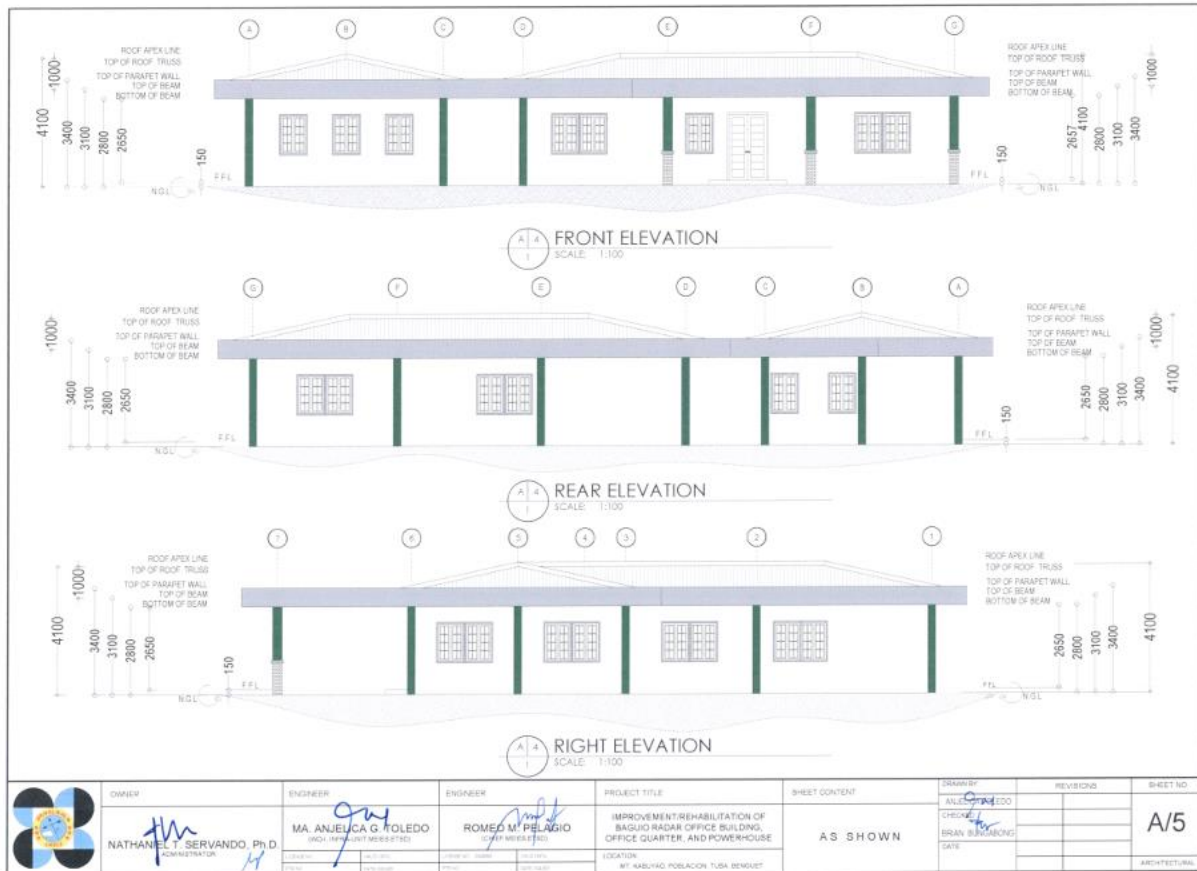

	OWNER NATHANIEL T. SERVANDO, Ph.D. CONSTRUCTION	ENGINEER MA. ANJELICA G. TOLEDO UCLL (PROFESSIONAL REGISTERED)	ENGINEER ROMEO M. PELAGIO UCLL (PROFESSIONAL REGISTERED)	PROJECT TITLE IMPROVEMENT/REHABILITATION OF BAGUIO RADAR OFFICE BUILDING, OFFICE QUARTER, AND POWERHOUSE	SHEET CONTENT AS SHOWN	DRAWN BY ANJELICA G. TOLEDO	REVISIONS	SHEET NO. A/5 ARCHITECTURAL
--	--	---	---	--	----------------------------------	---------------------------------------	------------------	--