

NOTE: BLUE DRAWINGS INDICATE EXISTING PANEL BOARDS.


SINGLE LINE DIAGRAM
SCALE: _____ NTS


	OWNER	ENGINEER		ENGINEER	PROJECT TITLE	SHEET CONTENT	DRAWN BY: ACMC	REVISIONS		SHEET NO.
	NATHANIEL T. SERVANDO, Ph.D. ADMINISTRATOR	DIOSDADO S. ORNUM WFS-III, EPSU-METTSS, ETSD		MAXIMO F. PERALTA Chief, ETSD		INSTALLATION OF ELECTRIC SERVICE FEEDER LINE AND ELECTRIC SERVICE ENTRANCE POST IN SL-PRSD BUILDING, LEGAZPI CITY, ALBAY	AS SHOWN	CHECKED:		E/1
								DATE:		
								APRIL 30, 2024		
LICENCE NO.:		VALID UNTIL:	LICENCE NO.:	VALID UNTIL:	LOCATION: LEGAZPI COMPLEX STATION, AIRPORT SITE, MAGAYON DR., BRGY. CRUZADA, LEGAZPI CITY, ALBAY				ELECTRICAL	
PTR NO.:		DATE ISSUED:	PTR NO.:	DATE ISSUED:						



- LEGEND:**
- PROPOSED SERVICE ENTRANCE POST
 - POWERHOUSE
 - EXISTING MANHOLE
 - PROPOSED MANHOLE
 - SL-PRSD BUILDING

 **FEEDER LINE LAYOUT**
SCALE: _____ NTS

	OWNER	ENGINEER		ENGINEER		PROJECT TITLE	SHEET CONTENT	DRAWN BY: ACMC	REVISIONS		SHEET NO.
	NATHANIEL T. SERVANDO, Ph.D. ADMINISTRATOR	DIOSDADO S. ORNUM WFS-III, EPSU-METTSS, ETSD		MAXIMO F. PERALTA Chief, ETSD		INSTALLATION OF ELECTRIC SERVICE FEEDER LINE AND ELECTRIC SERVICE ENTRANCE POST IN SL-PRSD BUILDING, LEGAZPI CITY, ALBAY	AS SHOWN	CHECKED:			E/2
		LICENCE NO.:	VALID UNTIL:	LICENCE NO.:	VALID UNTIL:	LOCATION:		DATE:			
		PTR NO.:	DATE ISSUED:	PTR NO.:	DATE ISSUED:	LEGAZPI COMPLEX STATION, AIRPORT SITE, MAGAYON DR., BRGY. CRUZADA, LEGAZPI CITY, ALBAY		APRIL 30, 2024			ELECTRICAL

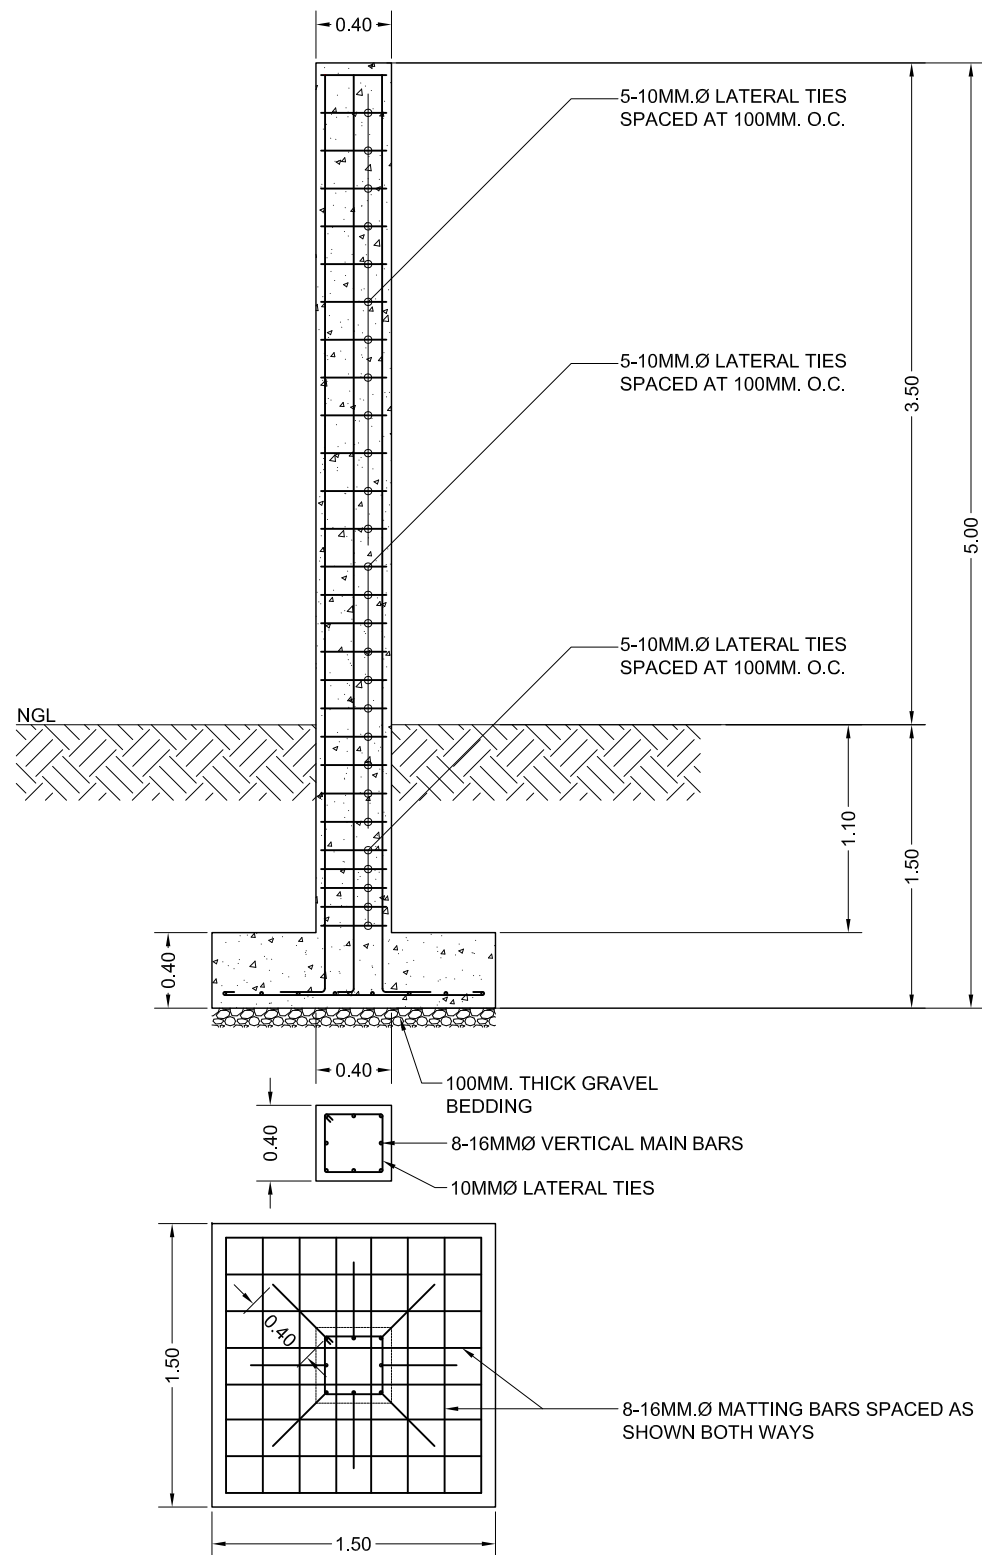


1
S-1

SERVICE ENTRANCE POST DETAILS

SCALE

1:40MTS.

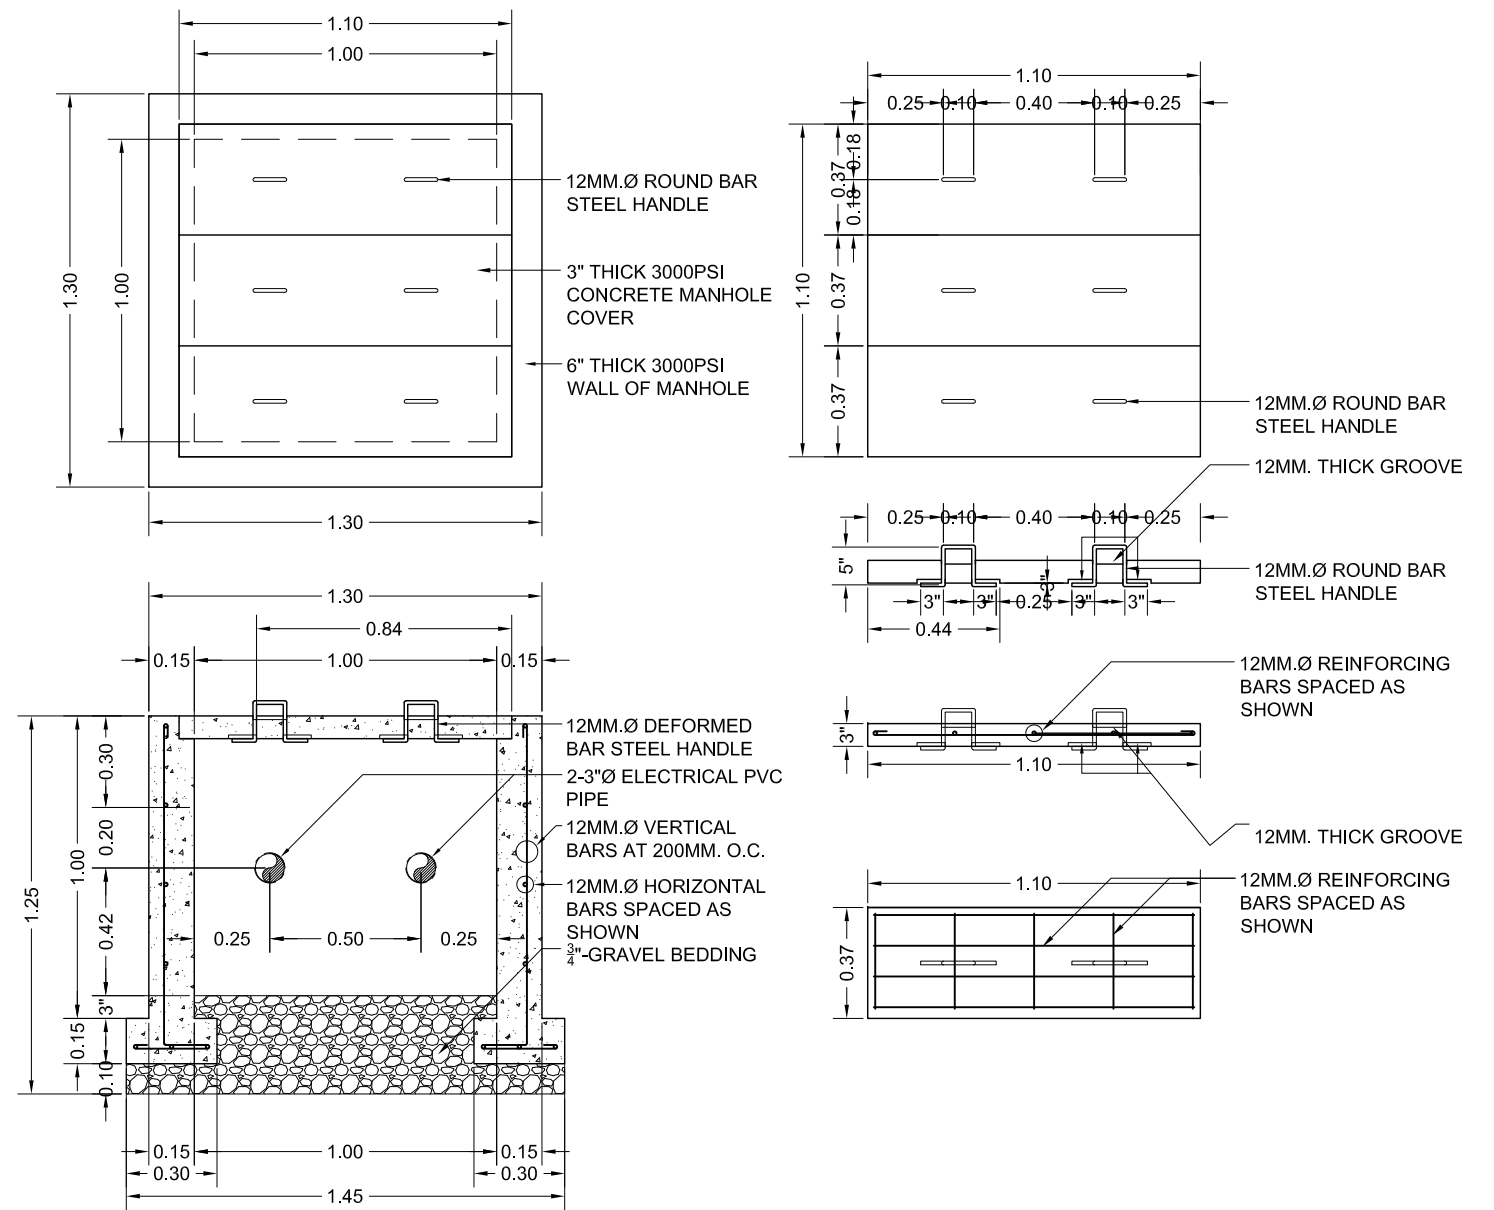

2
S-1

MANHOLE DETAILS

SCALE

1:25MTS.



OWNER	ENGINEER	ENGINEER	PROJECT TITLE	SHEET CONTENT	DRAWN BY:	REVISIONS	SHEET NO.
NATHANIEL T. SERVANDO, Ph.D. ADMINISTRATOR	BRIAN P. BUNGABONG WFS-II, INFRA UNIT	ROMEO M. PELAGIO CHIEF, MEIES	INSTALLATION AND CONSTRUCTION OF ELECTRIC SERVICE FEEDER LINE AND ELECTRIC SERVICE ENTRANCE POST IN SL-PRSD BUILDING, LEGAZPI, ALBAY	AS SHOWN	CHECKED:		S-1
	LICENCE NO.:	LICENCE NO.:	LOCATION: LEGAZPI, ALBAY		DATE:		STRUCTURAL
	VALID UNTIL:	VALID UNTIL:					
	PTR NO.:	PTR NO.:					
	DATE ISSUED:	DATE ISSUED:					